

NOTE:

The Contractor is to check and verify all building and site dimensions, levels and section points before construction begins and report any discrepancies to the Architect immediately. The drawing must be read with and checked against any structural or other specialist drawings provided.

The Contractor is to comply in all respects with the current Building Regulations whether or not specifically stated on these drawings.

This drawing is not intended to show details of foundation or ground conditions. Each area of ground relied upon to support the structure of foundation be provided.

LEGEND

FD

Fire Rated Doorset

Fixtures and fittings

Gas cooker

Cigarette Vending Machine

Telephone

Comprehensive (Amp or 50W)

P

Pool Table

Services

FAG

Fire Alarm Panel

AD

Automatic fire detector

MC

Manual Call Point

Speaker

Sounder Beacon

E

Emergency lighting (Fluorescent Downlight)

Emergency Exit light

QW legend (external)

9-line water fire extinguisher

9-line water fire extinguisher

Dry powder fire extinguisher

Carbon Dioxide fire extinguisher


Foam fire extinguisher

CCTV camera

Mechanical extraction fan

AC

Air-conditioning unit

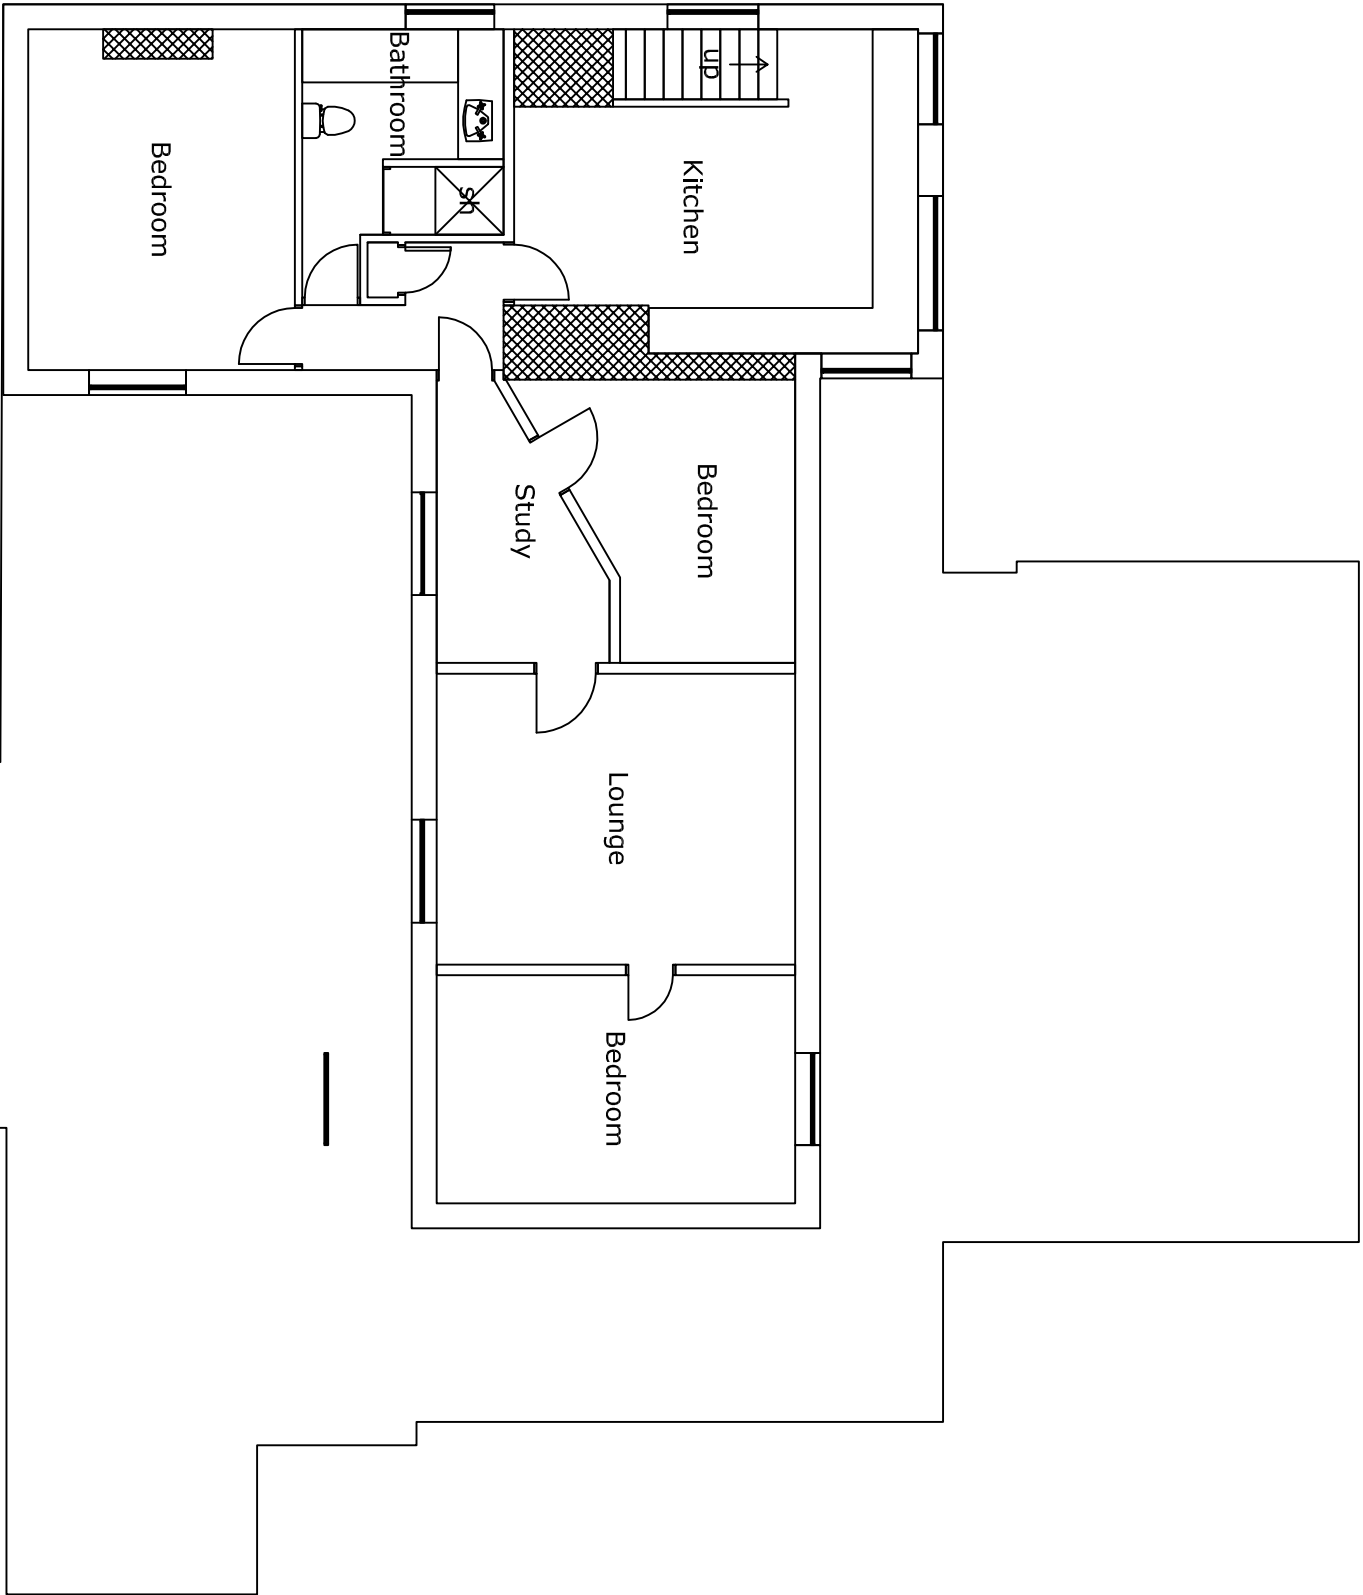

First Floor Plan
Scale 1:100

Project Name/Client	Drawn By	Scale	Date
PS	KG	1:200@A3	14/10/08
Arch/Drawn/Revised	Drawn/Revised		Rev.
BES			